


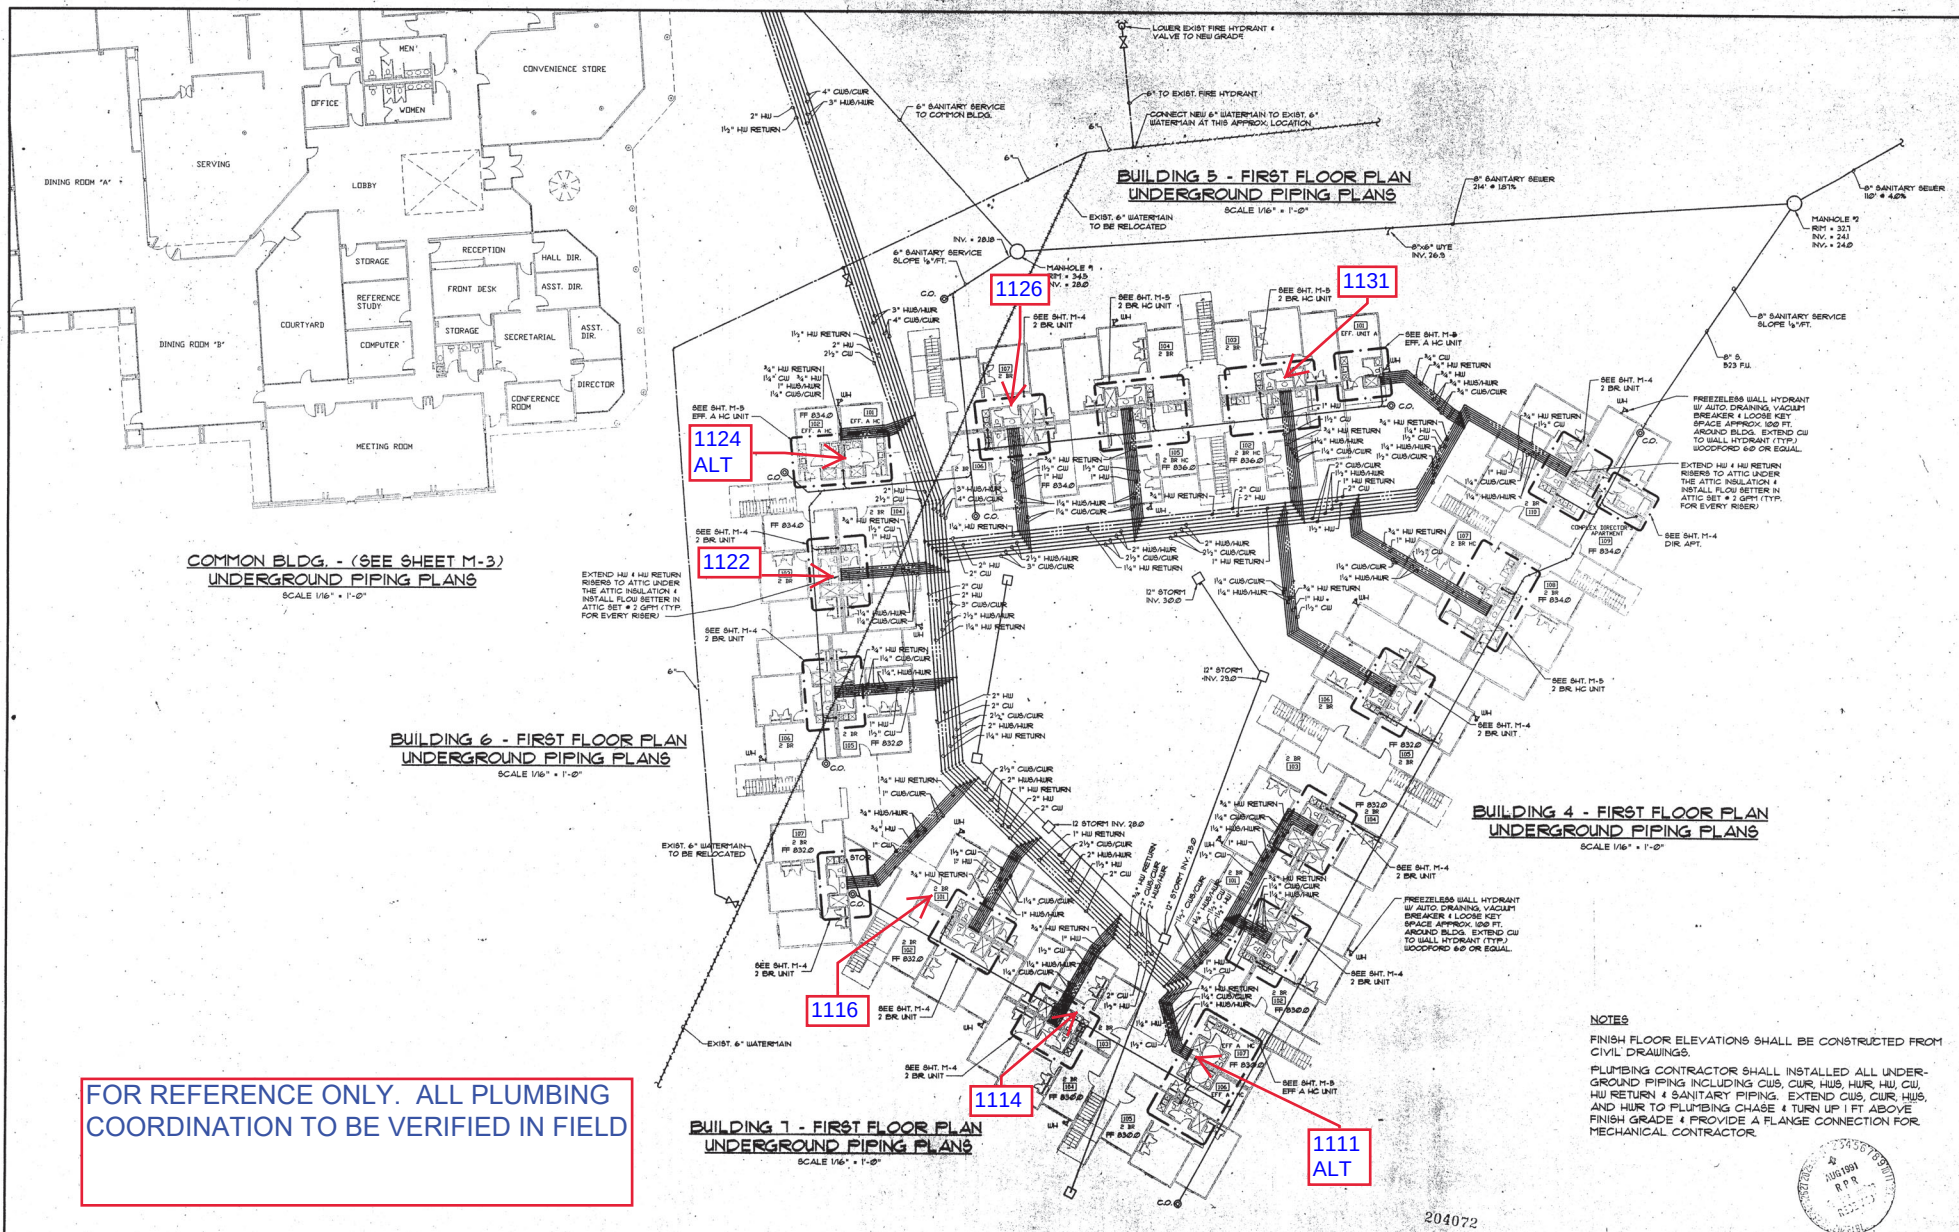

STEVEN MICHAEL TYLER, P.E.
MECHANICAL ENGINEER
2011 Shadowood Ct., Columbia, S.C. 29212

NKU **RESIDENTIAL VILLAGE DEVELOPMENT**
HIGHLAND HEIGHTS, KENTUCKY

SHEET TITLE
BUILDINGS 4, 5, 6 & 7
UNDERGROUND PIPING PLANS

REVISIONS	BY	Drawn	SMT

M2